


MANTEL TETER ARCHITECTS
929 WALNUT STREET, SUITE 700 | KANSAS CITY, MISSOURI 64108
TOLL-FREE: 877.215.5800 | P: 816.931.5800 | F: 816.531.7537
WWW.MANTELTETERARCHITECTS.COM


Project Description:
Timothy Lutheran Church
HWY 7 & Wyatt Road
Blue Springs, Missouri 64014

PROJECT #: 08-543
ISSUE DATE: 10/20/2008
DRAWN BY: ARS
CHECKED BY: SKP
REVISIONS:
1.
2.
3.
4.
5.

SHEET No.
A8.1
REFLECTED CEILING PLAN

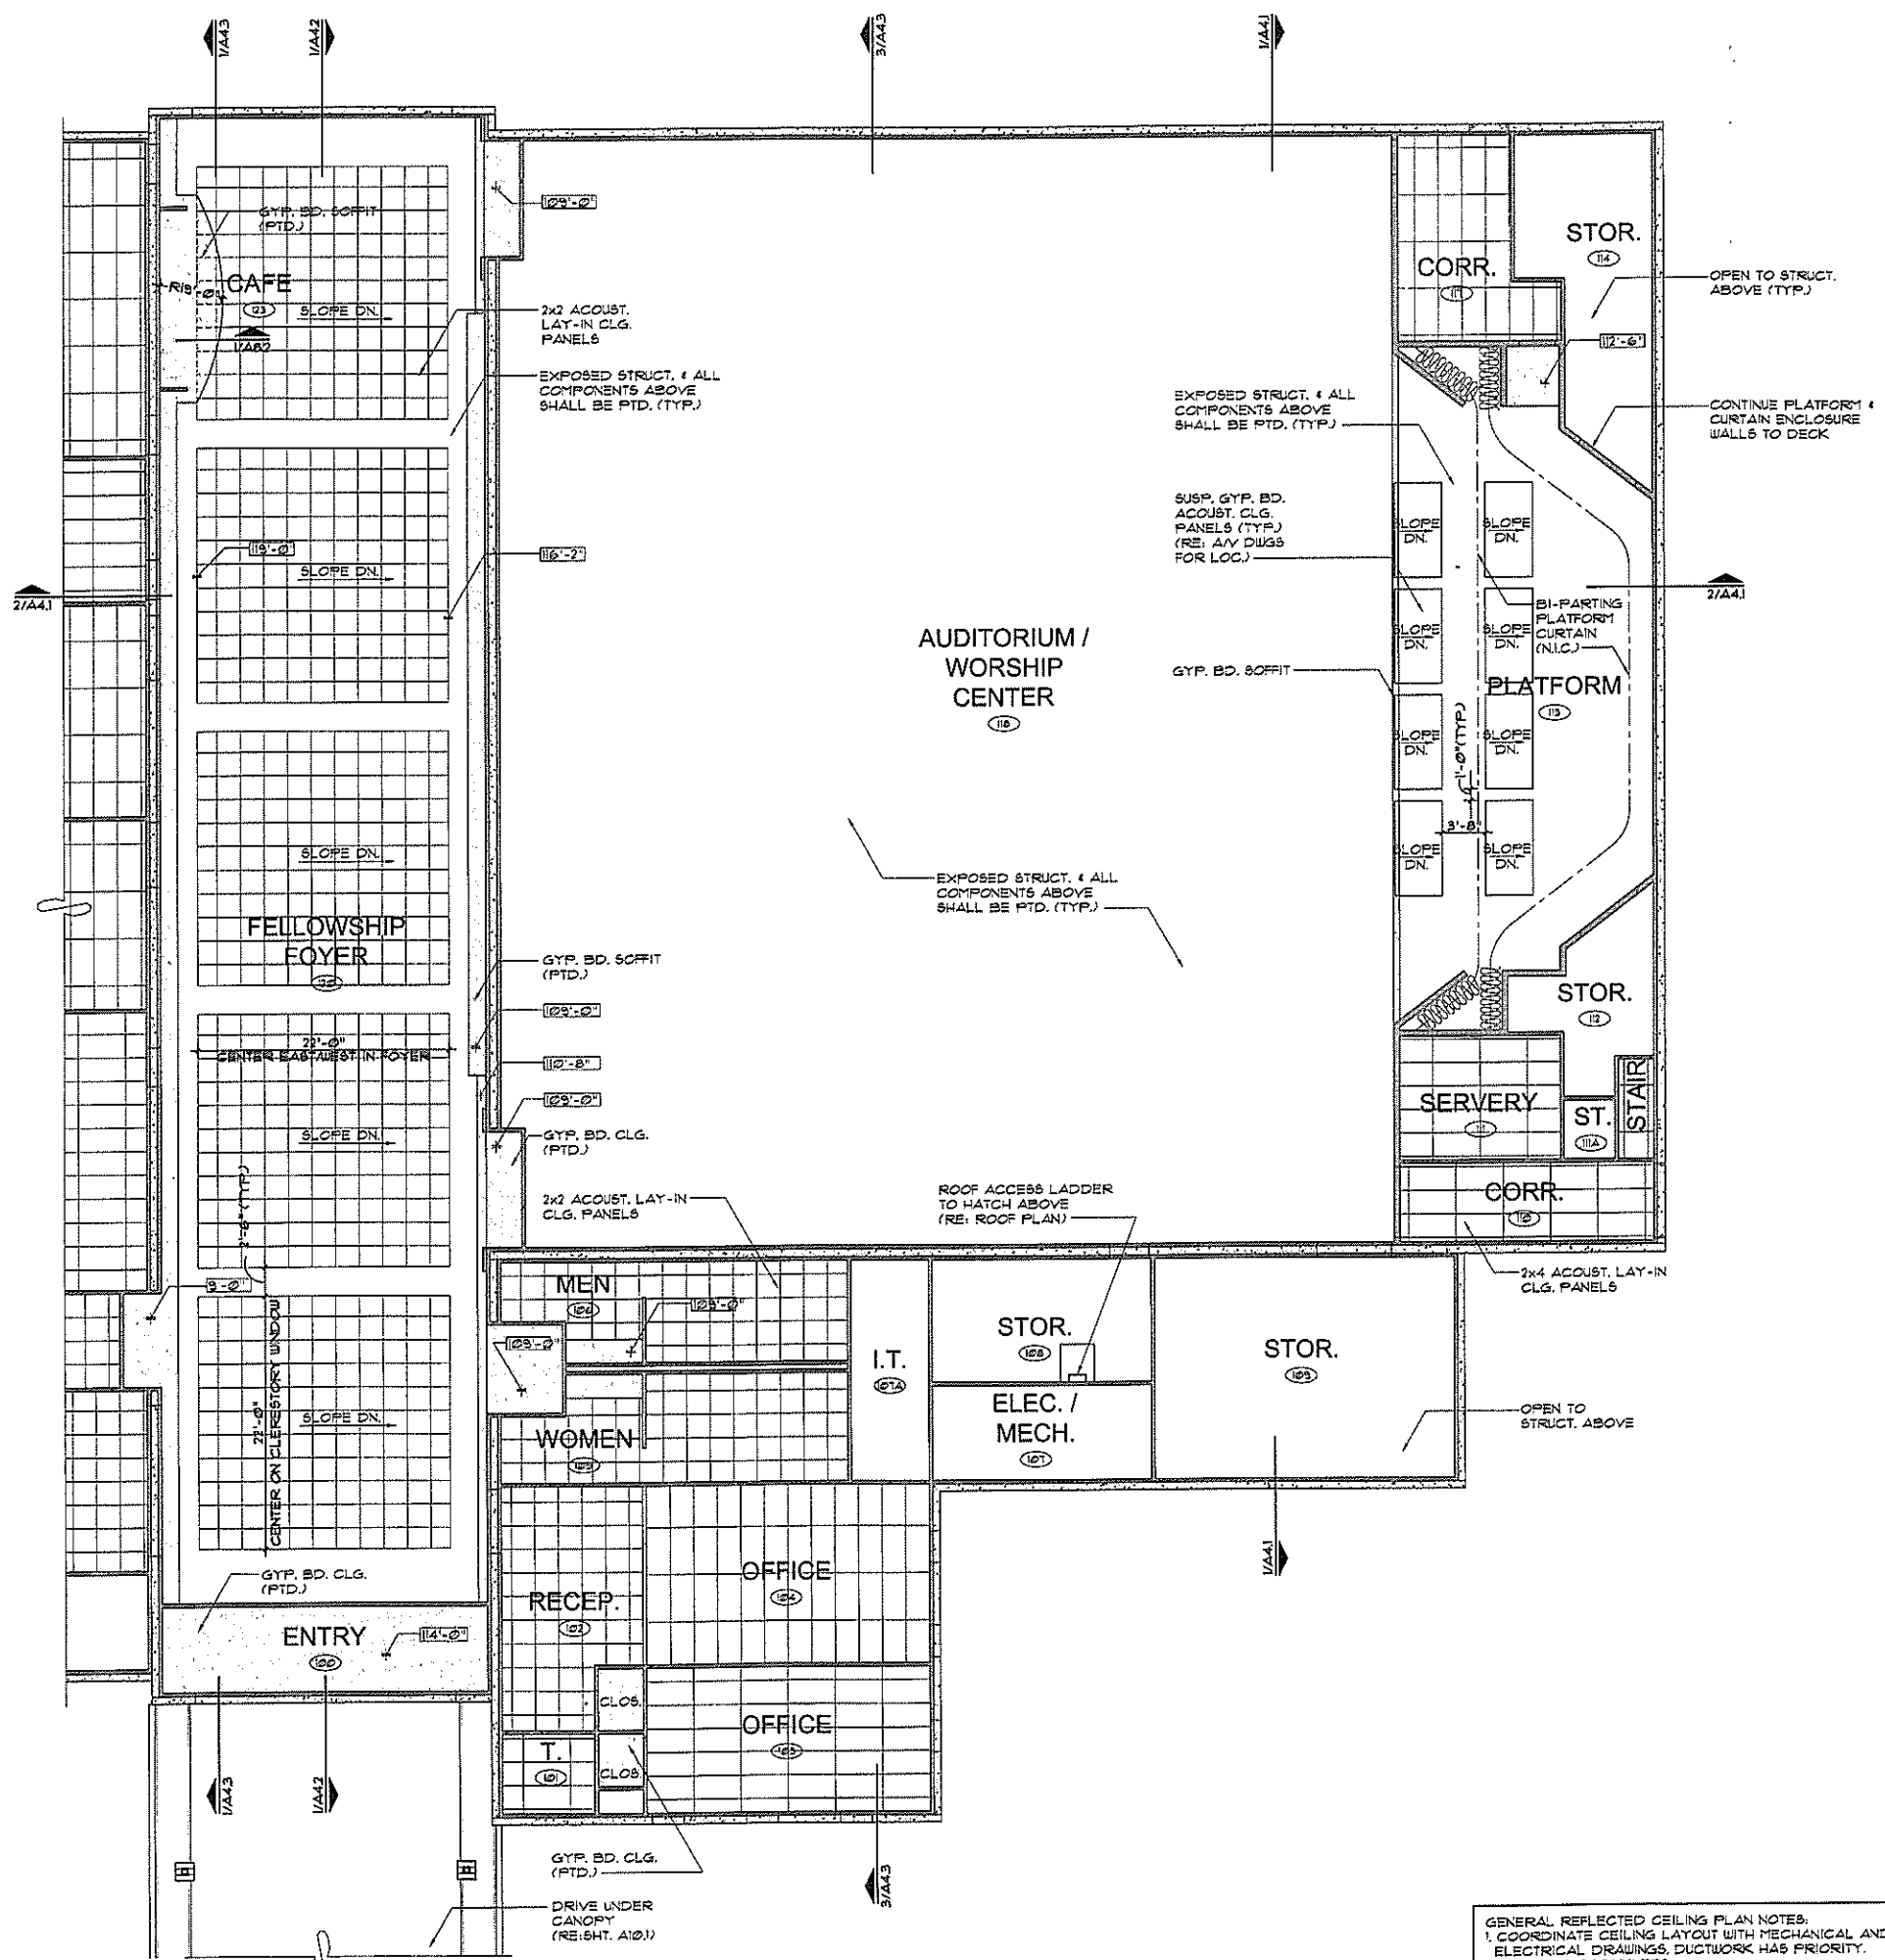

GENERAL REFLECTED CEILING PLAN NOTES:
1. COORDINATE CEILING LAYOUT WITH MECHANICAL AND ELECTRICAL DRAWINGS. DUCTWORK HAS PRIORITY.
COORD. W/ SPRINKLER.
2. SPRINKLER CONTRACTOR TO COORDINATE WITH MECHANICAL CONTRACTOR FOR LAYOUT. DUCTWORK HAS PRIORITY.

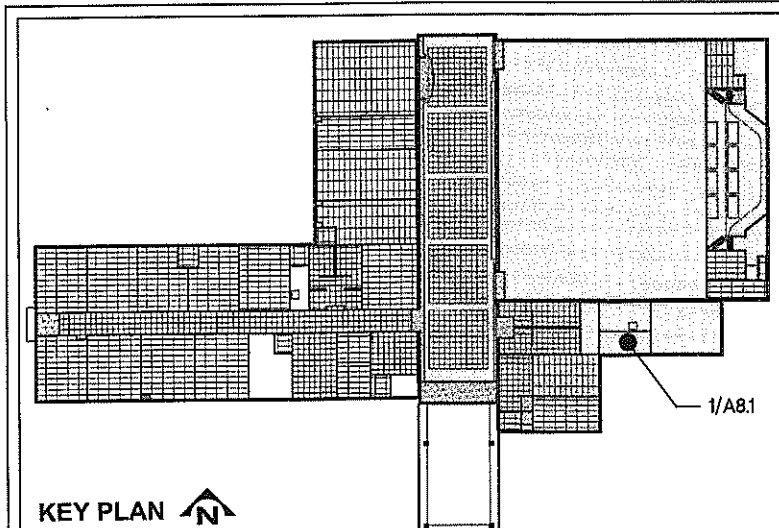

REFLECTED CEILING PLAN

KEY PLAN