





MANTEL TETER ARCHITECTS
929 WALNUT STREET, SUITE 700 | KANSAS CITY, MISSOURI 64108
TOLL-FREE: 877.315.5600 | P: 816.931.5600 | F: 816.531.7537
WWW.MANTELTETERARCHITECTS.COM

Project Description:
Timothy Lutheran Church
HWY 7 & Wyatt Road
Blue Springs, Missouri 64014

PROJECT #: 08-543
ISSUE DATE: 10/20/2008
DRAWN BY: ARS
CHECKED BY: SKP

REVISIONS:
1. _____
2. _____
3. _____
4. _____
5. _____

SHEET No.
A8.2
REFLECTED CEILING PLAN & DETAILS

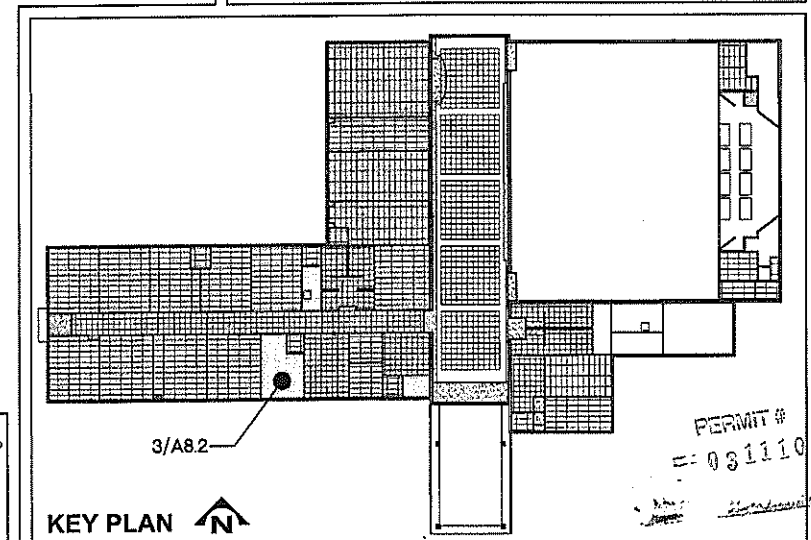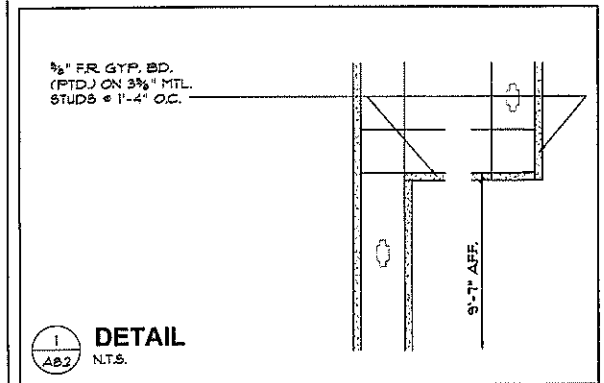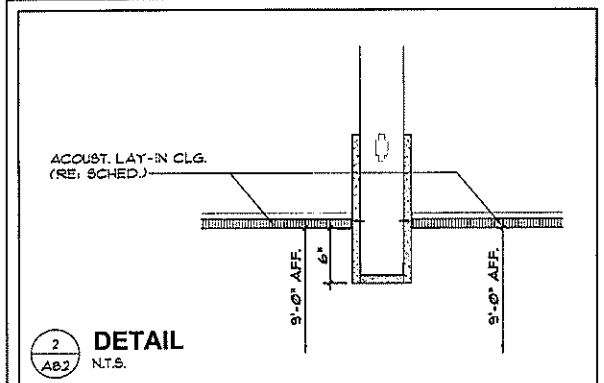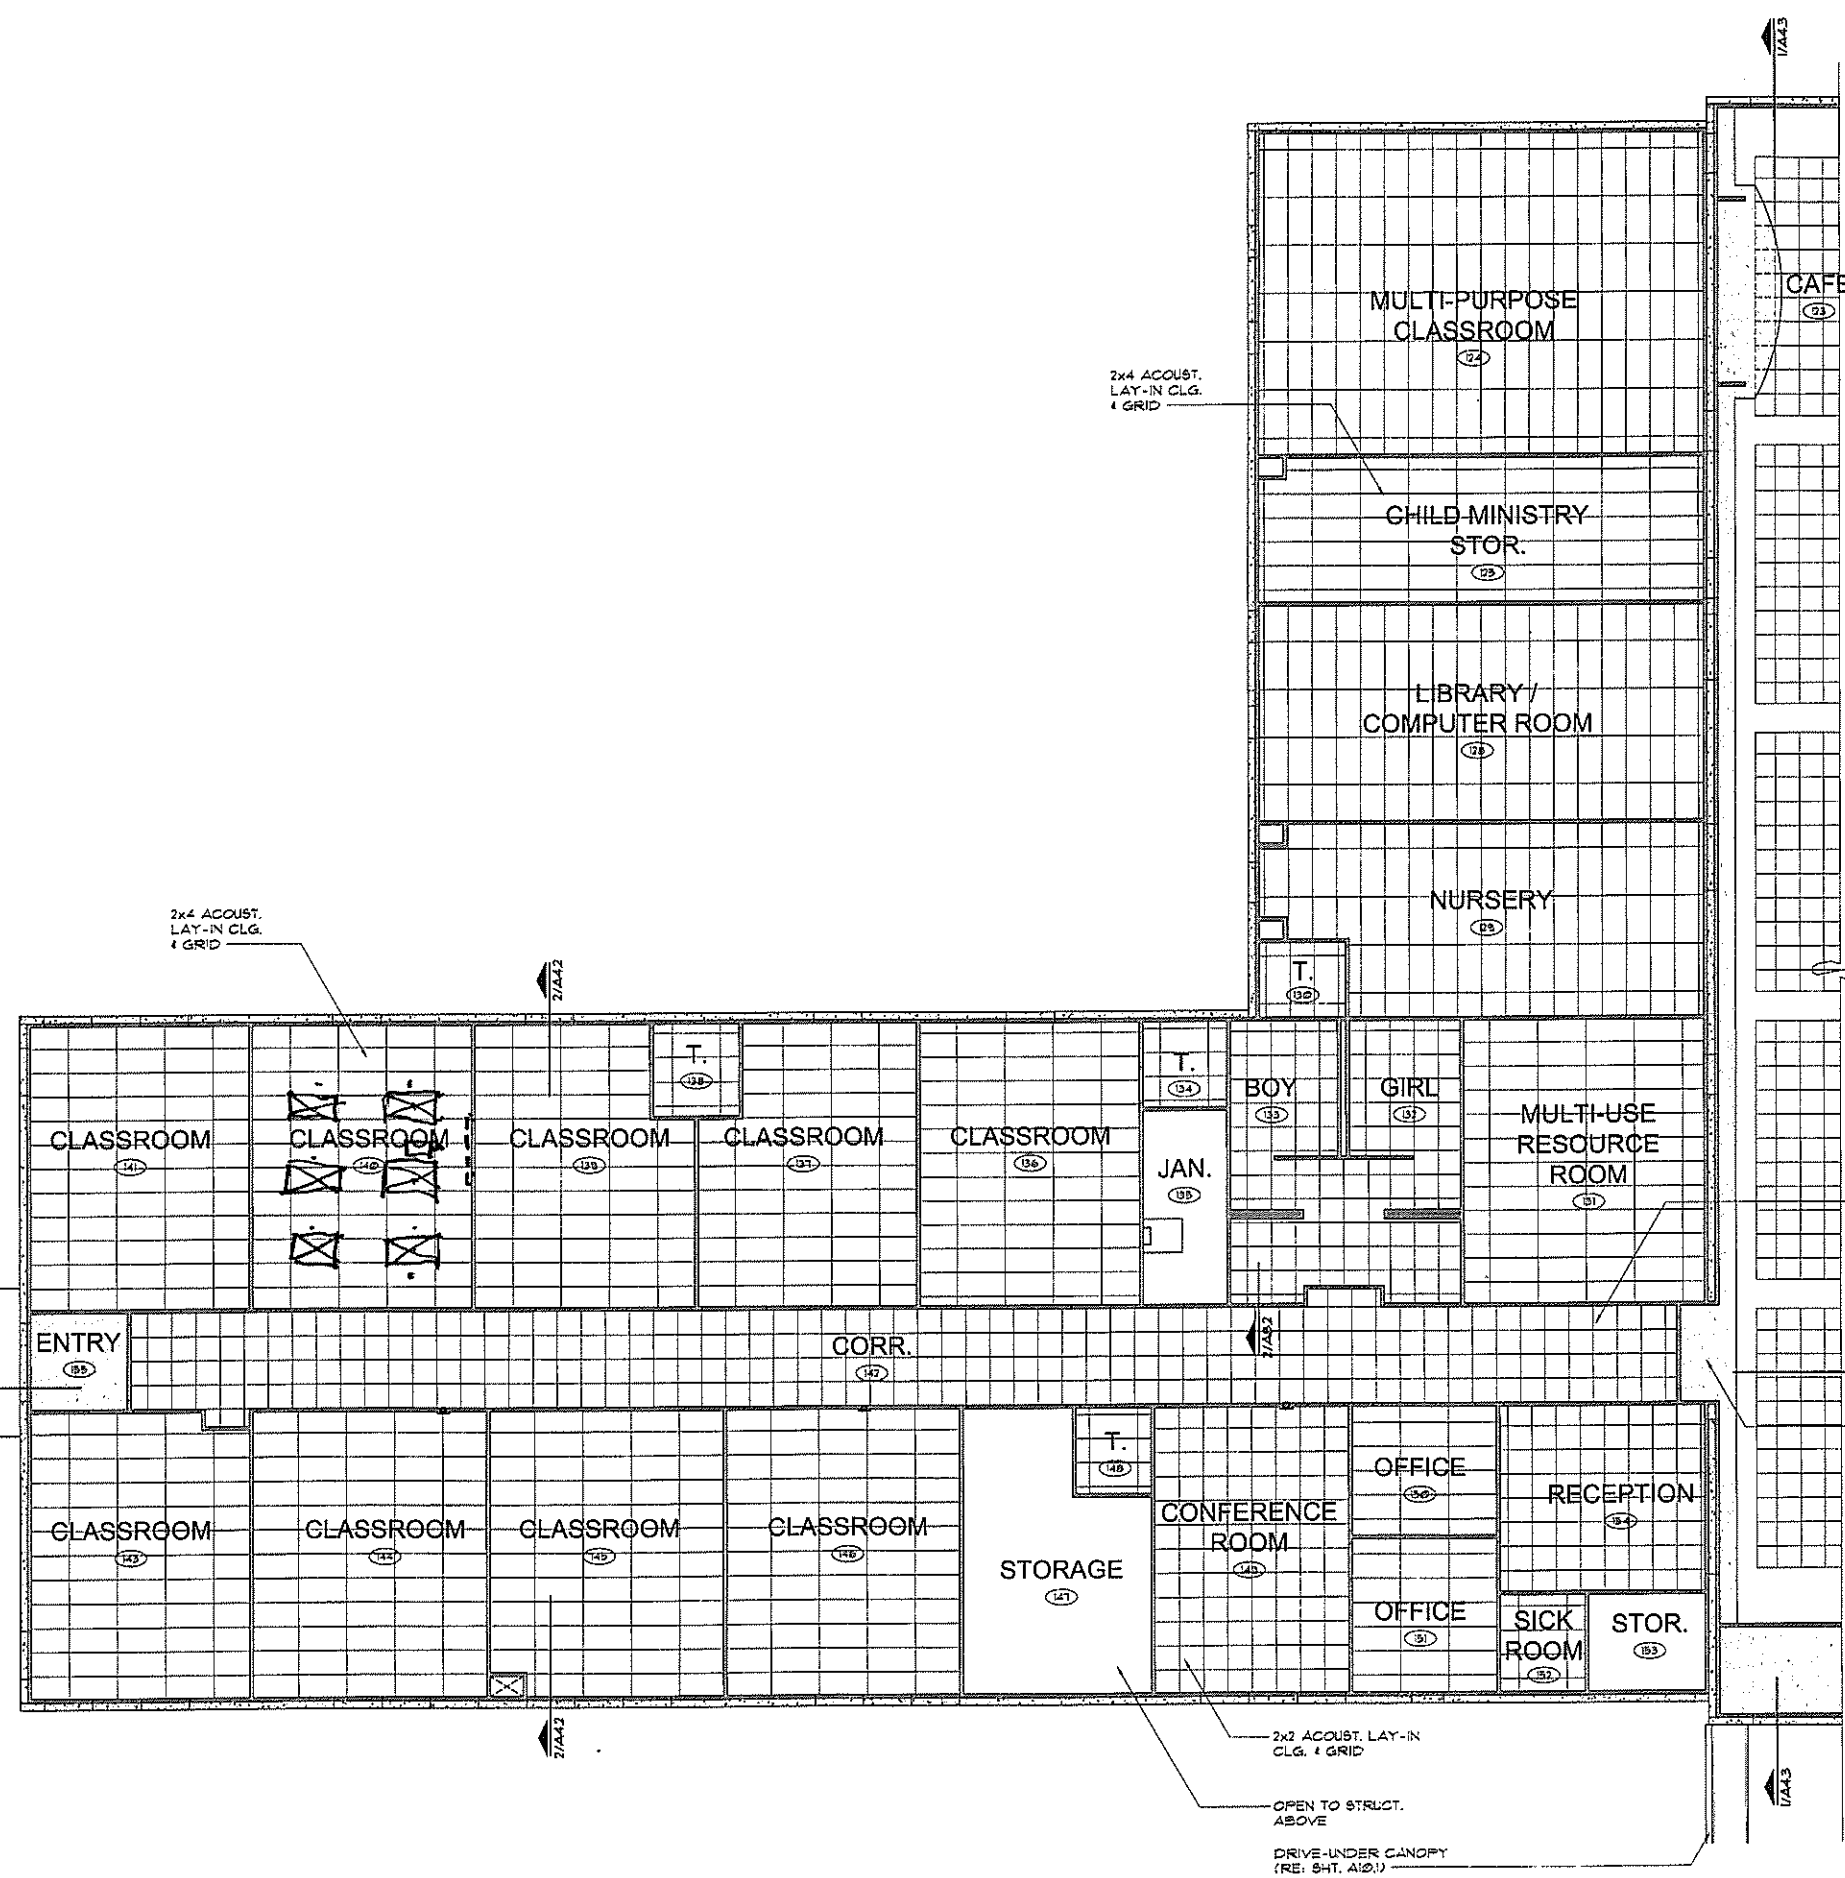

GENERAL REFLECTED CEILING PLAN NOTES:
1. COORDINATE CEILING LAYOUT WITH MECHANICAL AND ELECTRICAL DRAWINGS. DUCTWORK HAS PRIORITY.
COORD. W/ SPRINKLERS
2. SPRINKLER CONTRACTOR TO COORDINATE WITH MECHANICAL CONTRACTOR FOR LAYOUT, DUCTWORK HAS PRIORITY